


### AIR DISTRIBUTION SCHEDULE

SUPPLY				RETURN/EXHAUST/TRANSFER									
NAME	TAG	QTY	SIZE	MODEL	CFM	LOG	NAME	TAG	QTY	SIZE	MODEL	CFM	LOG
HWR FLOOR	FS-1		4'x10"	411	0-560		TI15	RS-1	24x24"	360RL	300-800		
TI15	CD-1		8'x6"	300RL	0-500								
TI15	SP-1		8'x6"	300RL	0-500								

NOTE: ALL SUPPLY GRILLES AND DIFFUSERS TO HAVE VOLUME DAMPERS

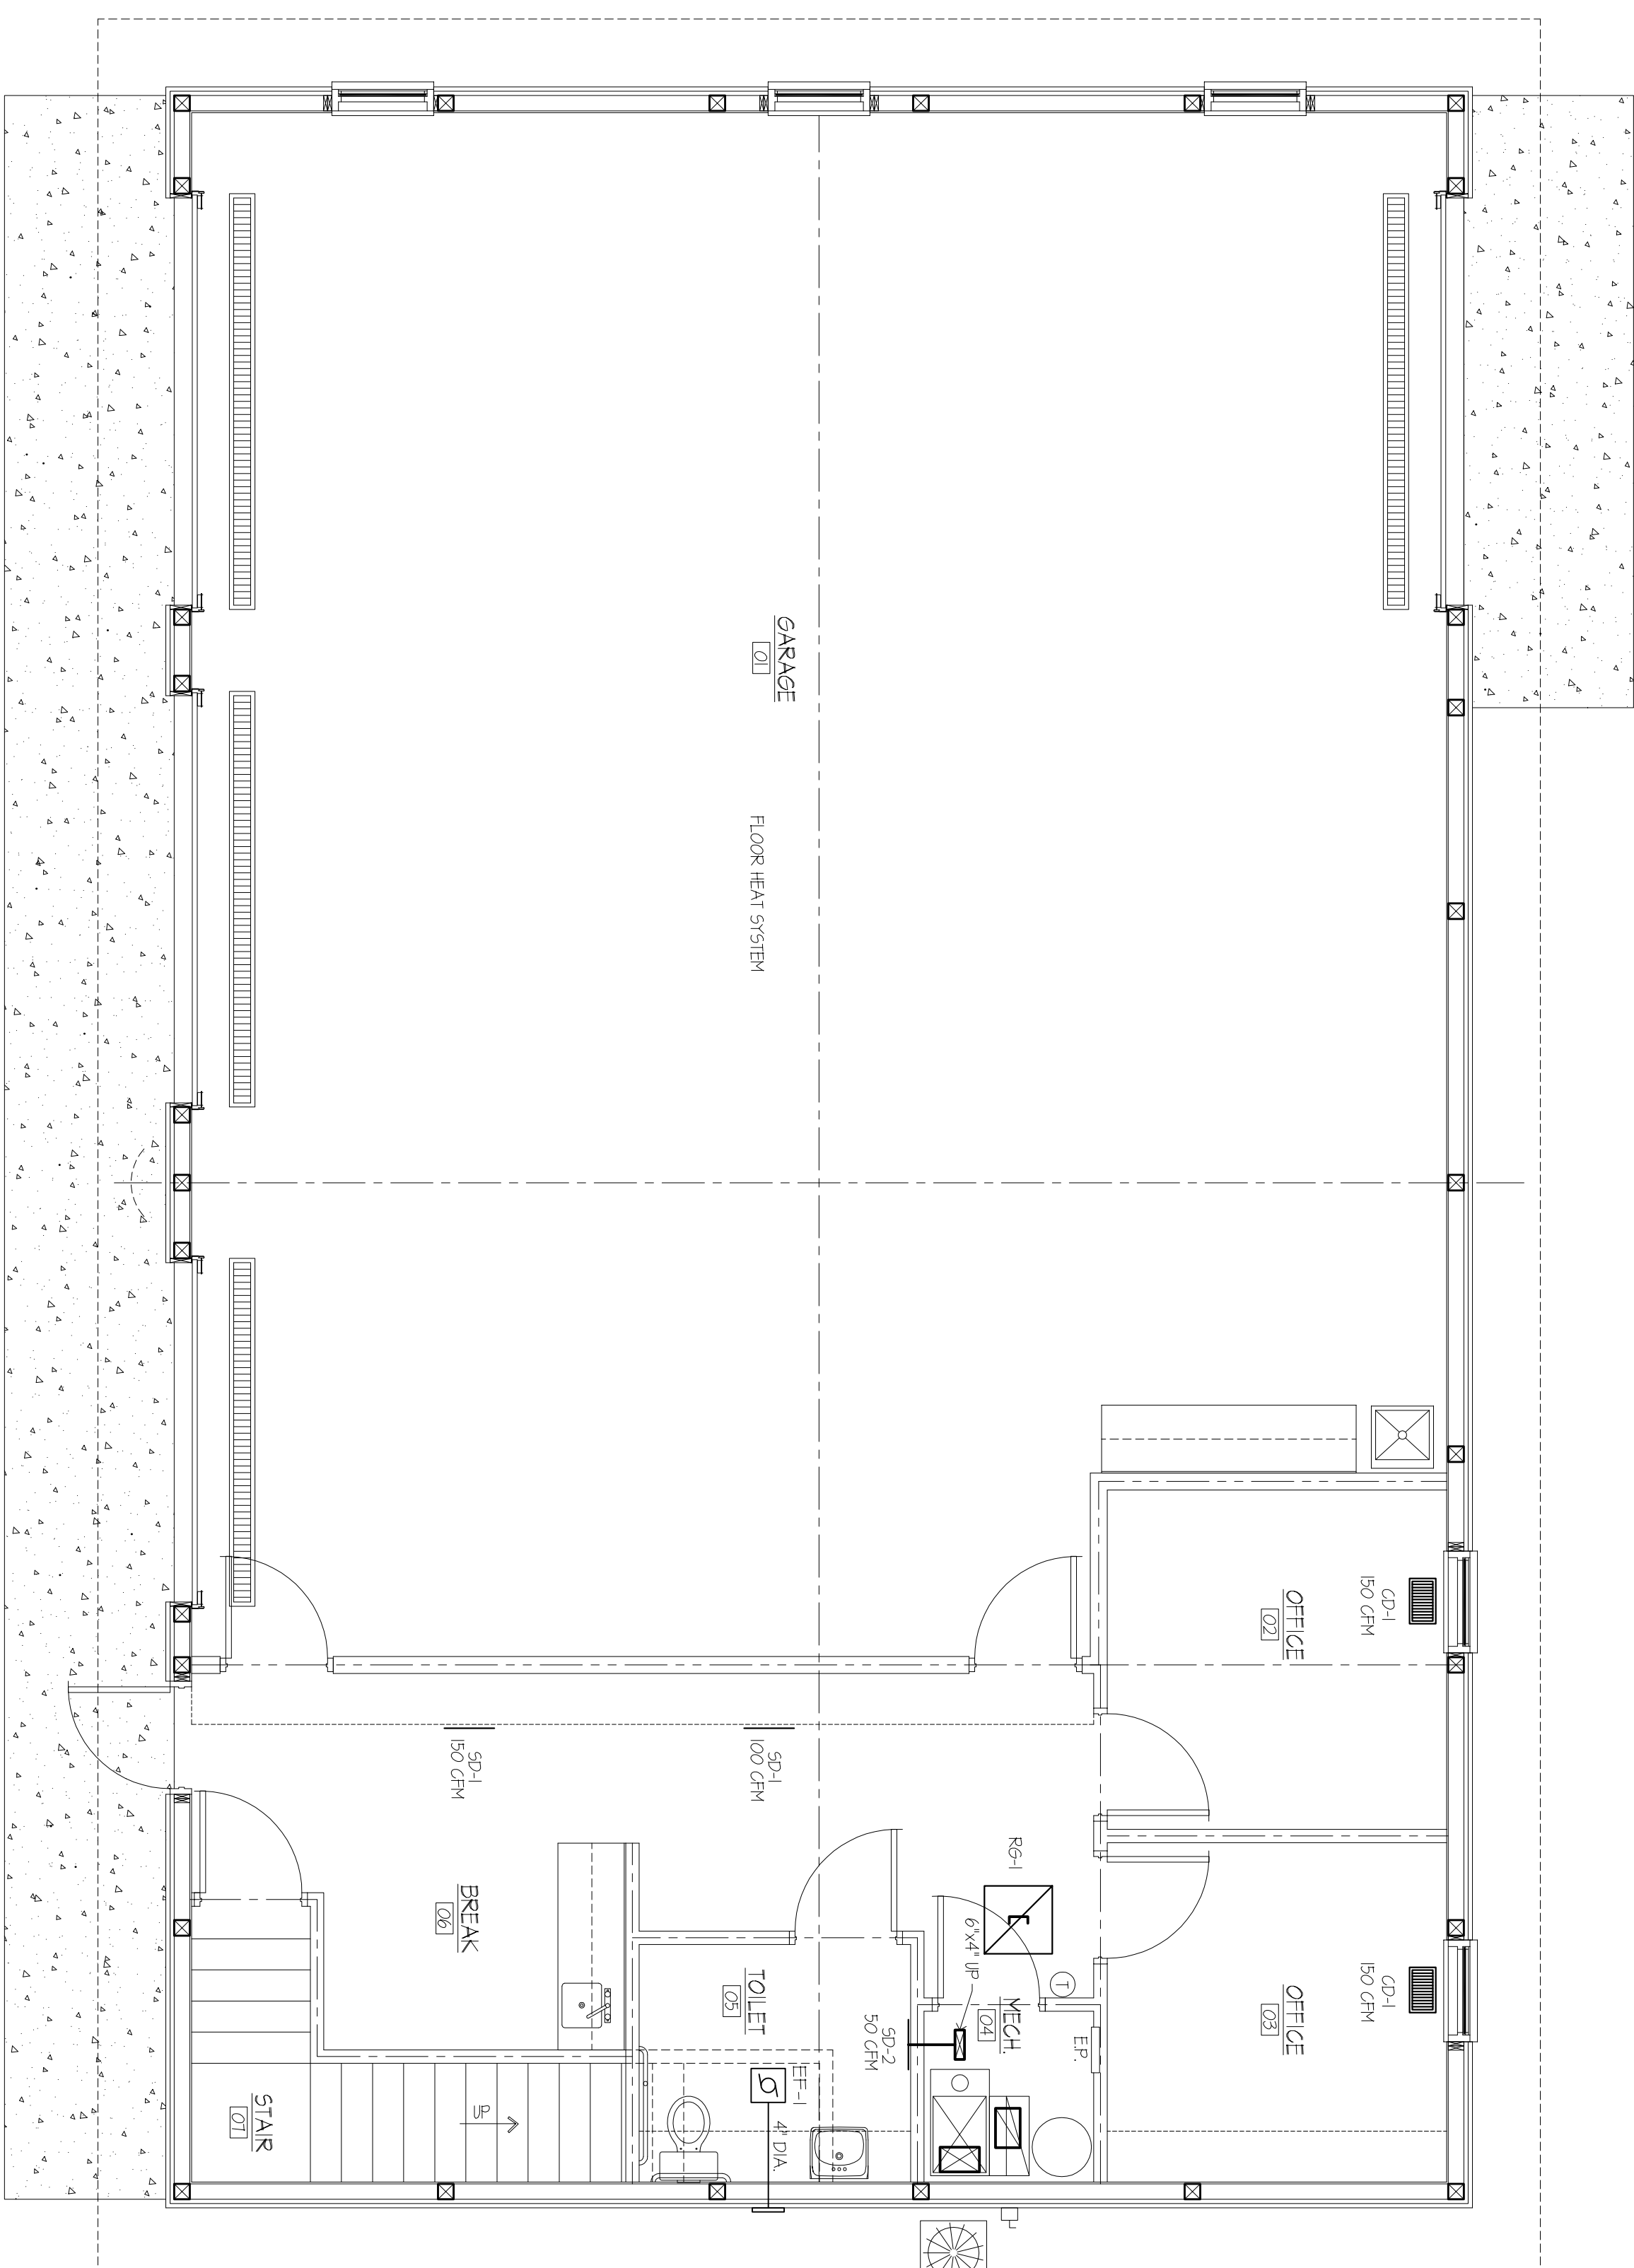

**LOWER LEVEL MECHANICAL PLAN**  
SCALE: 1/4" = 1'-0"

### EXHAUST FAN SCHEDULE


UNIT NO.	LOCATION	MODEL NO.	CFM	S.F.	H.P.	FRMKT.	CONTROL	VOLT	PHASE	HZ	REMARKS
EF-1	TOILET	60-124	75	1			WALL SWITCH	115	1	60	

BASED ON CODE

### SPLIT SYSTEM AIR CONDITIONING UNIT SCHEDULE

UNIT NO.	LOCATION	MODEL NO.	CFM	S.F.	H.P.	HEATING INPUT MBH	COOLING COIL		CONDENSOR COIL # 2		ELECTRICAL	
							MODEL NO.	SIZE	MODEL NO.	KVA	VOLT	PHASE
F-1	MECH ROOM	1600	25	5		48,000	-	4 TON	-	230	3	60
T	SEE PLAN											

PROVIDE UNIT WITH FACTORY INSTALLED DISCONNECT.

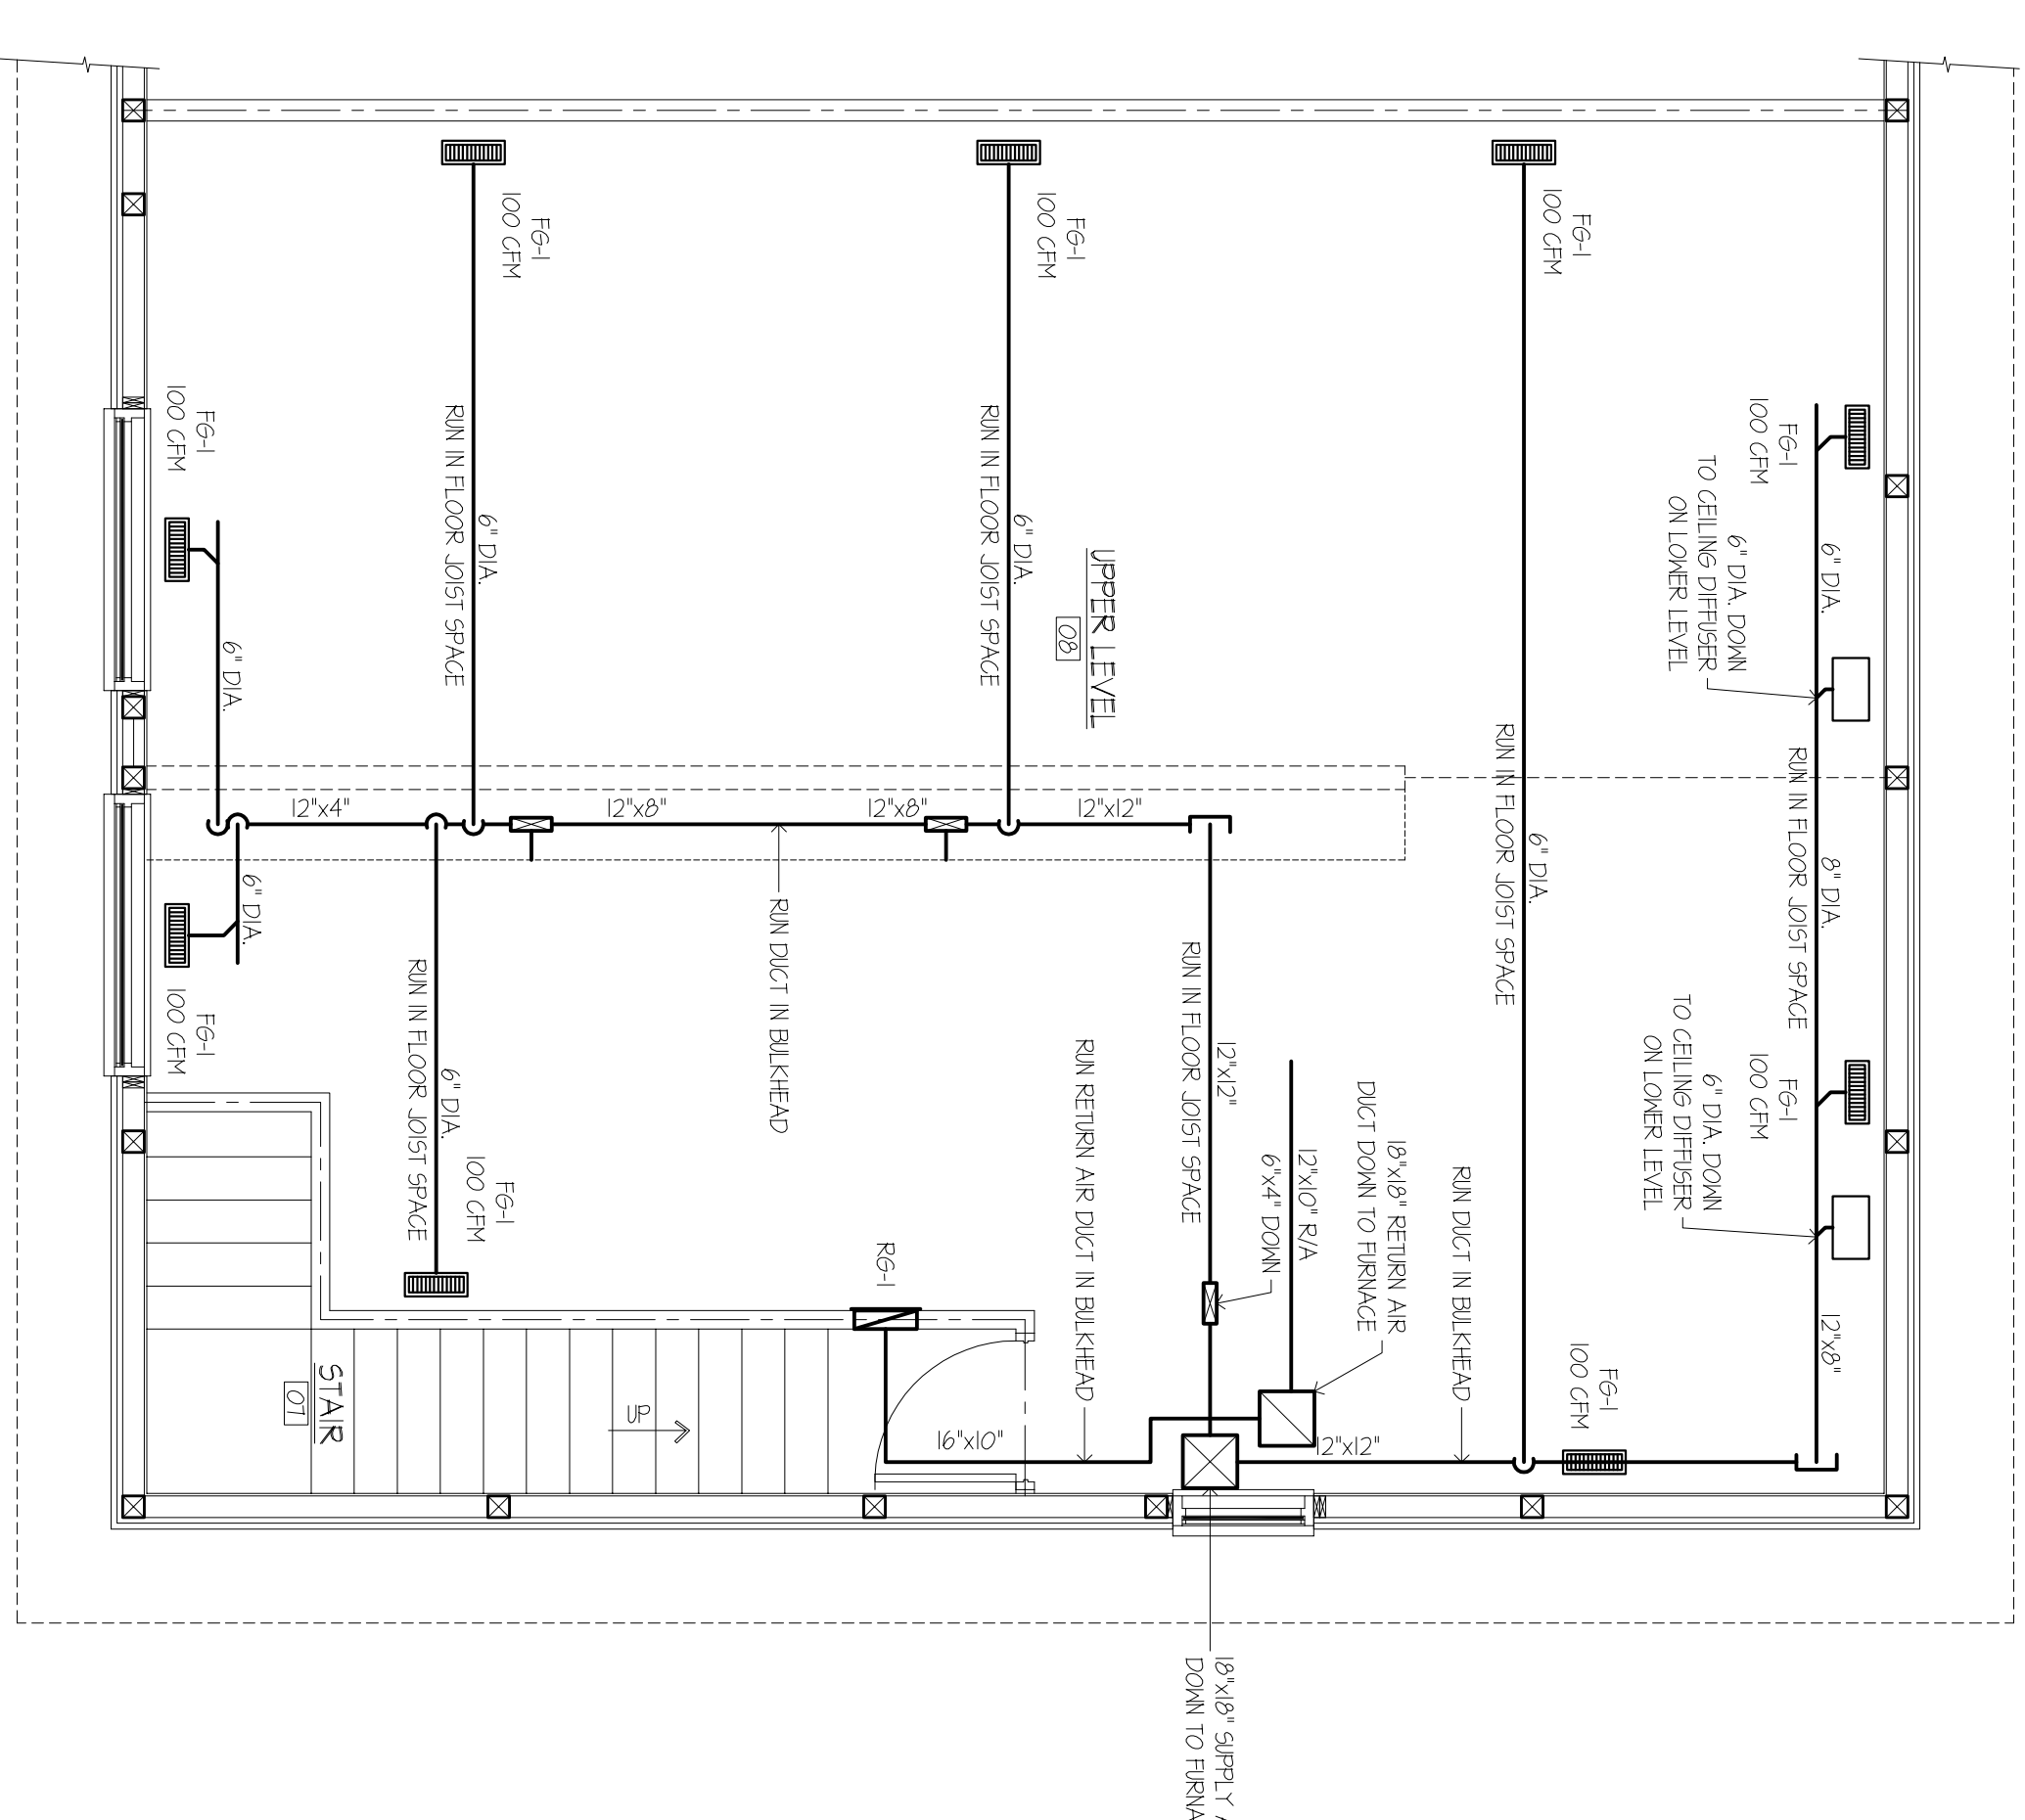

**UPPER LEVEL MECHANICAL PLAN**  
SCALE: 1/4" = 1'-0"

## MECHANICAL PLAN

HOWARD L. OVERBEEK  
ARCHITECT, P.C.

198 EAST CENTRE  
PORTAGE, MICHIGAN

PHONE (269) 323-2422  
FAX (269) 323-2440

PROJECT NO.  
0000

DATE  
01/03/17

REVISION

NEW BUILDING FOR:  
**GULL LAKE SEWER AND WATER AUTHORITY**  
7722 N. 37TH STREET  
RICHLAND, MICHIGAN 49083

SHEET  
MI